


- 1** 40" Telecom Panel:
5' Svc Loop
- 2** A/V Wallplates
15' Svc Loop


☎	= Telephone = 1 Cat6 to 1
⏏	= Data = 1 Cat6 to 1
📺	= Cable/Sat = 1 RG6 to 1
SG	= Single Gang Low-Voltage Bracket
DG	= Double Gang Low-Voltage Bracket
TG	= Triple Gang Low-Voltage Bracket
RI	= Specialized Rough-In Bracket

All Cables to be Labeled With Room Name

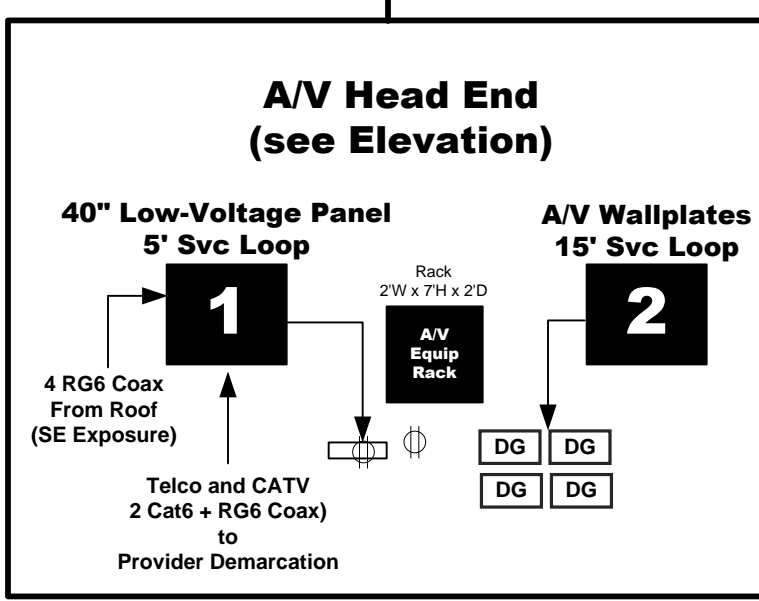


1/21/15 Scale: 1/4" = 1'


Low Voltage Plan

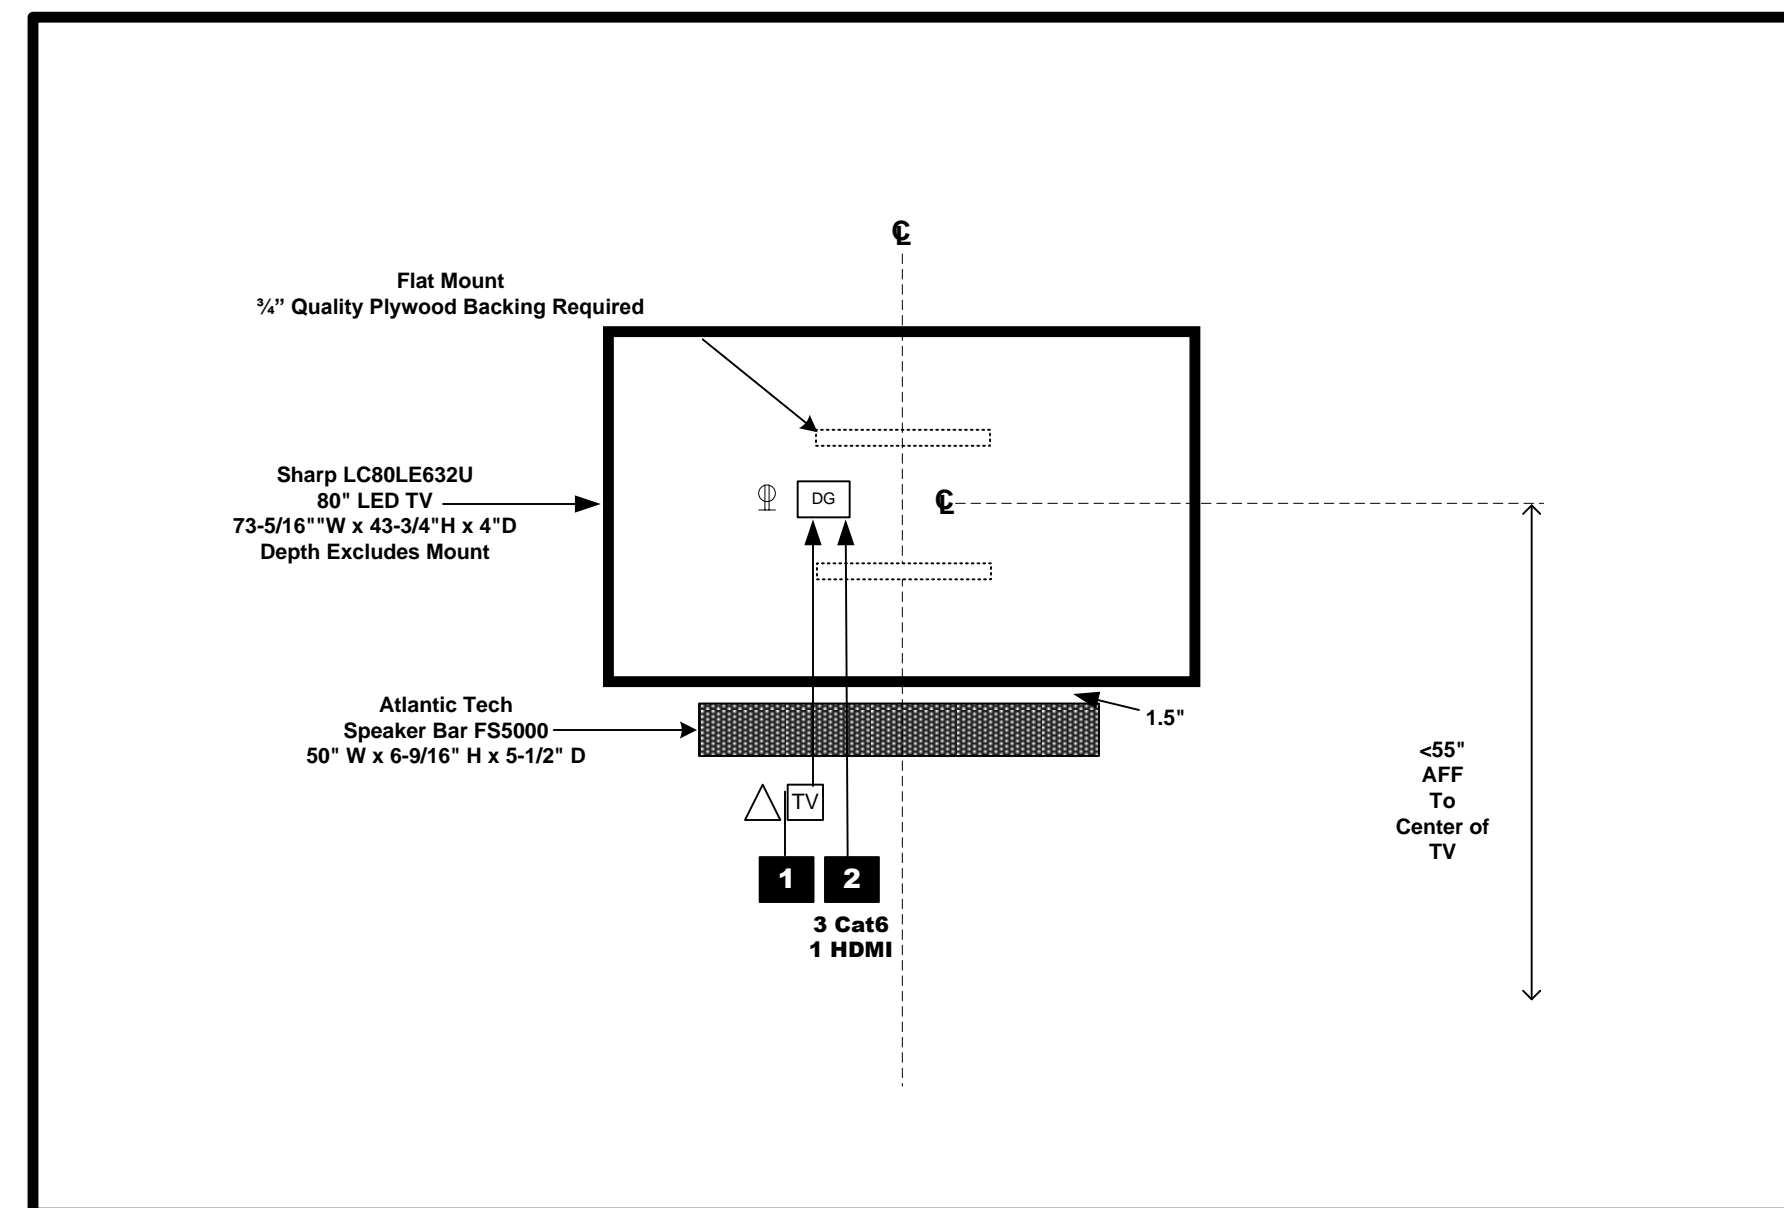


Den TV

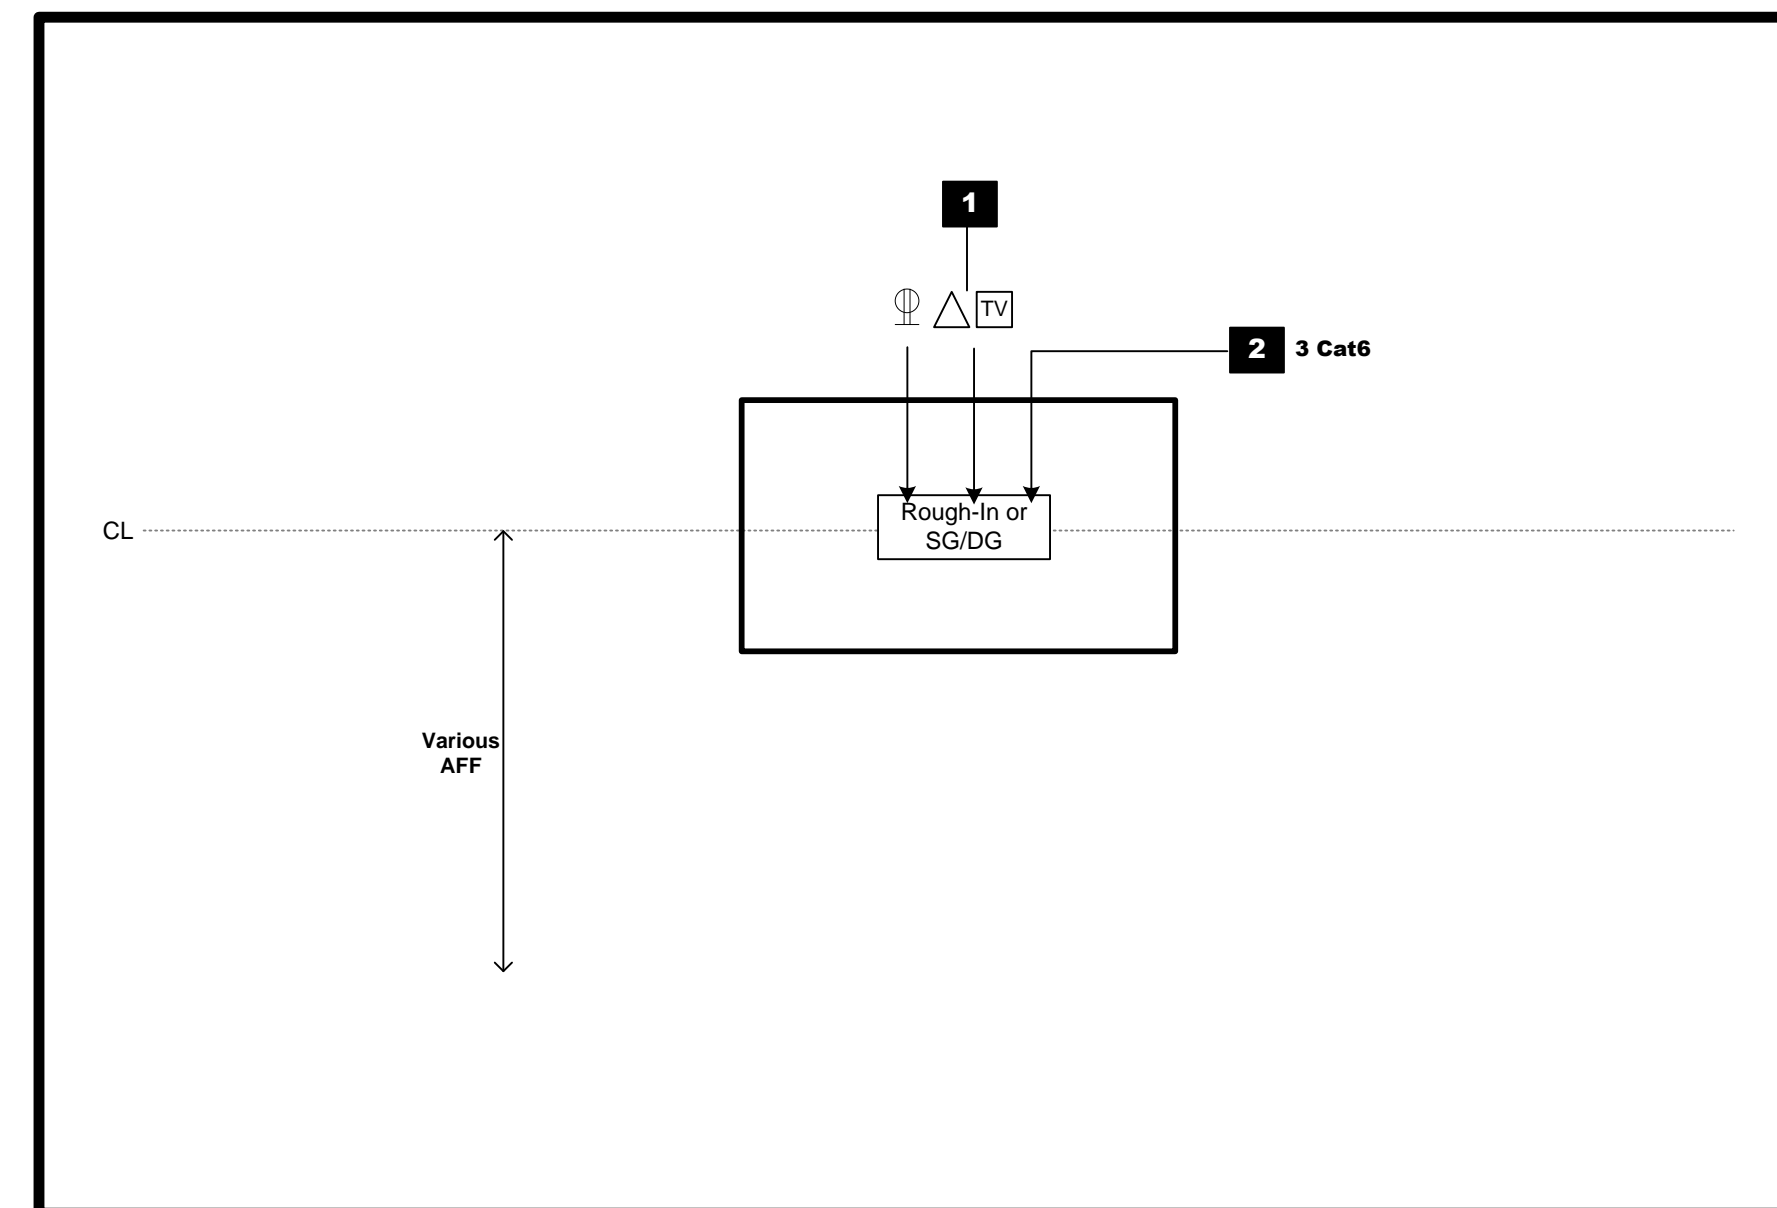

Other TV's

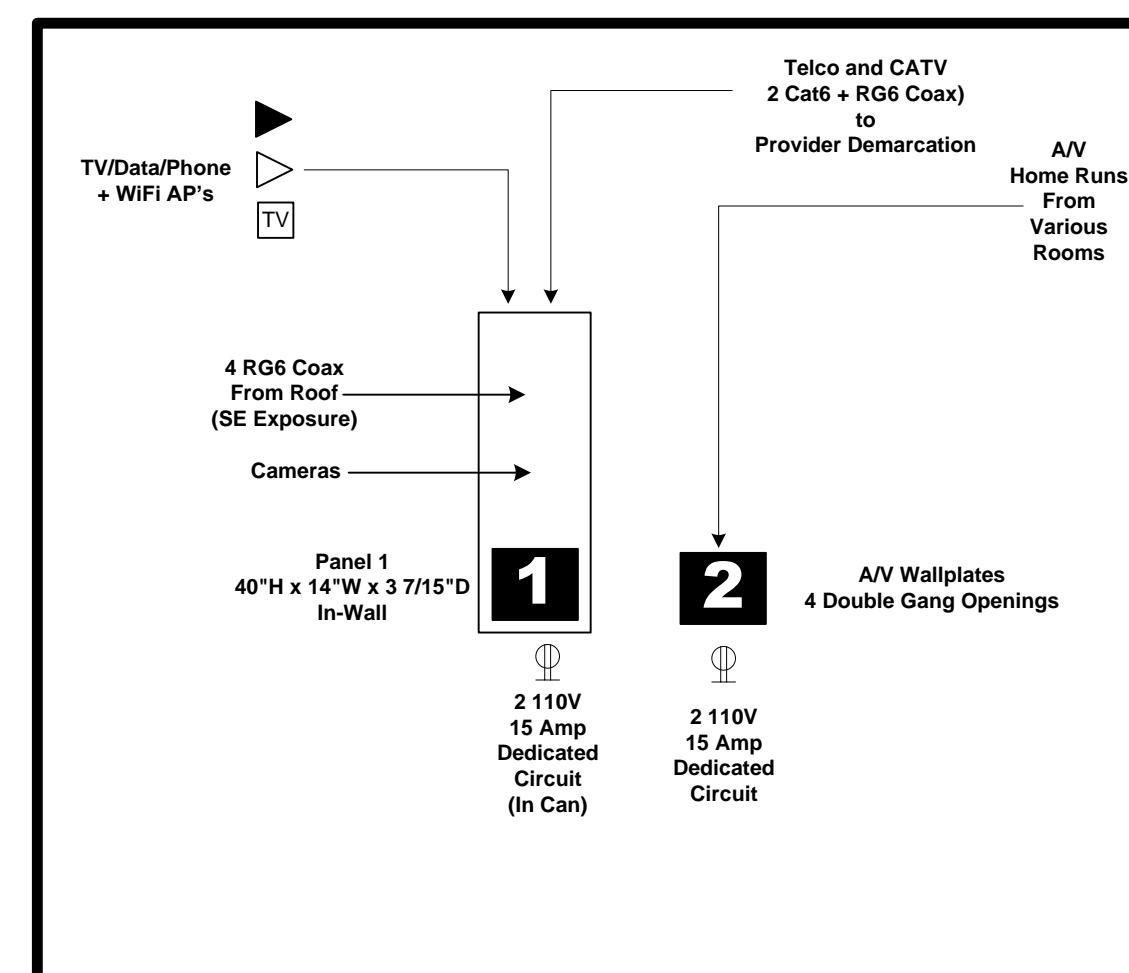

Low-Voltage Wiring Destinations

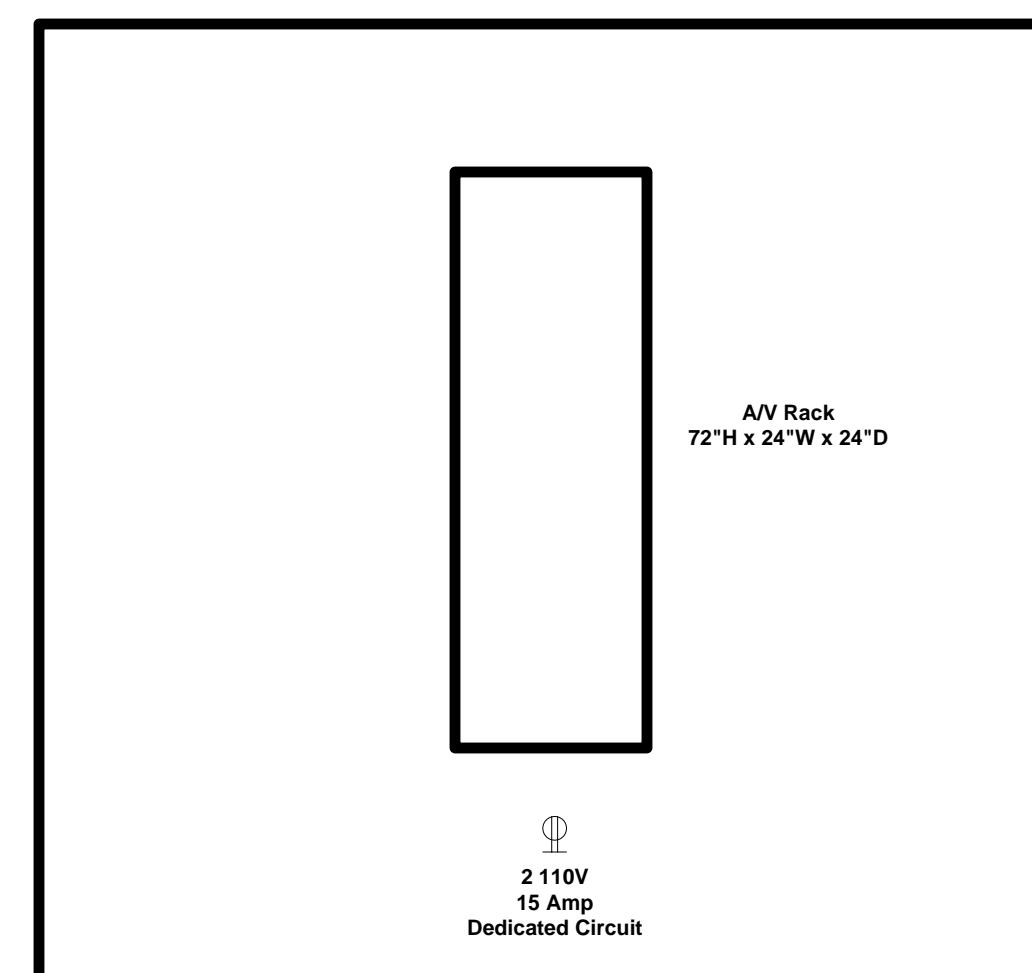

A/V Rack

1 40" Telecom Panel:
5' Svc Loop

2 A/V Wallplates
15' Svc Loop

	= Telephone = 1 Cat6 to 1
	= Data = 1 Cat6 to 1
	= Cable/Sat = 1 RG6 to 1
	= Single Gang Low-Voltage Bracket
	= Double Gang Low-Voltage Bracket
	= Triple Gang Low-Voltage Bracket
	= Specialized Rough-In Bracket

1/21/15

Low Voltage
Plan